


THIS COPY IS PROVIDED ON A RESTRICTED BASIS AND IS NOT TO BE USED IN ANY WAY DETRIMENTAL TO THE INTERESTS OF PANDUIT CORP.

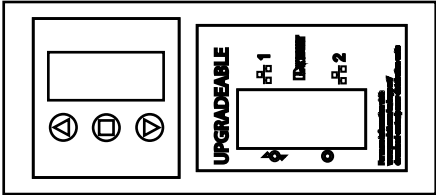


DETAIL A
(SCALE 4X)


PANDUIT P/N	WEIGHT
QD0B1L2BN0861	17 lb (7.7 kg)

- NOTES:
- IDENTIFICATION: 33" VERTICAL, MIXED (6) C-13 & (2) C-19 NETWORKED SECONDARY UNIT
208V / 30A / SINGLE-PHASE POU


PART NO.	COLOR
QD0B1L2BN0861	BLACK
 - ACCESSORY COMPONENTS:
(4) #10-32 x 1/2" MOUNTING SCREWS
(4) #12-24 x 1/2" MOUNTING SCREWS
(2) #10-32 LOCKING COLLAR SCREWS
(2) L-BRACKETS
 - DIMENSIONS IN PARENTHESES ARE METRIC (mm).
 - POWER (A,V,PF,KWH) MONITORING CAN ALSO BE ACCESSED REMOTELY VIA ETHERNET CONNECTION.
 - UPLINK CAN BE USED TO DAISY CHAIN TO THE PRIMARY UNIT TO HELP MINIMIZE SWITCH PORT USAGE.
 - UL® & c-UL® LISTED 60950.
 - RoHS COMPLIANT.
 - VISIT OUR ON-LINE CATALOG AT WWW.PANDUIT.COM FOR A CURRENT LIST OF PRODUCTS APPLICABLE FOR USE WITH THIS PART.
 - MAXIMUM AVAILABLE INPUT POWER = 5 KW
 - INSTALLATION SHALL COMPLY WITH ALL APPLICABLE NATIONAL, STATE, AND LOCAL CODES.

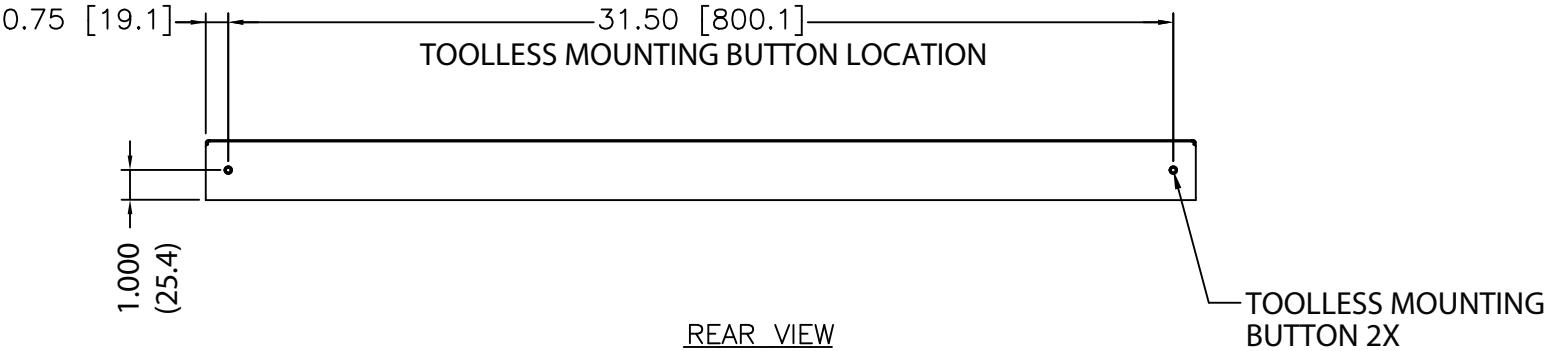

REAR VIEW

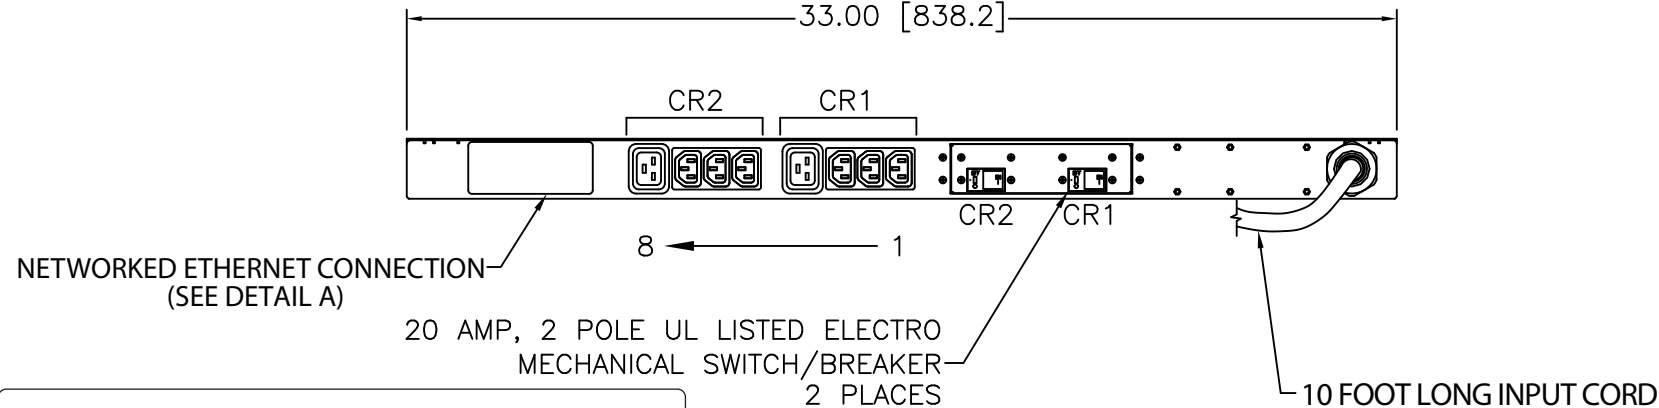

TOP VIEW

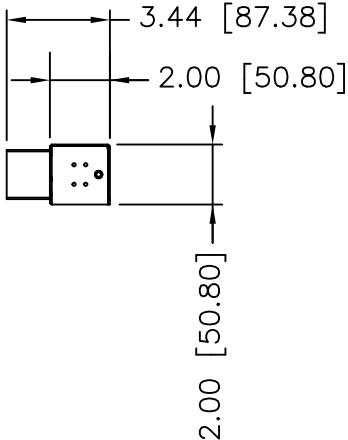

RIGHT SIDE VIEW

PLUG
30 AMP, 250V, SINGLE-PHASE
TWIST LOCK
NEMA L6-30P

SIX (6)
RECEPTACLES
15 AMP, 250V
STRAIGHT BLADE
IEC 60320/C13

TWO (2)
RECEPTACLES
20 AMP, 250V
STRAIGHT BLADE
IEC 60320/C19

REV	DATE	BY	CHK	DESCRIPTION	ECN	R	CUST	SUP	OTH
03A	2-12-15	MRWA	CRN	E. UPDATED NOTE 4 D. REMOVED "ENVIRONMENTAL MONITORED" FROM NOTE 1 & TITLE C. REMOVED CONNECTION CORD FROM ACCESSORIES	09V098HP				
02A	12-30-14	MRWA	CTN	B. REVISED MECHANICAL LAYOUT OF UNIT	09V098HP				
01A	8-15-12	PIP	MRWA	A. UPDATED OVERLAY.	09V098HP				
00A	11-16-11	MRWA	KRKE	RELEASED TO PRODUCTION	09V098HP				

MODEL FILENAME 09V098HP/03.PRT	
CAD FILENAME/LAYERS 09V098HP_DC/03A.PRT	
PANDUIT CORP. TINLEY PARK, ILLINOIS	
33" VERTICAL, MIXED (6) C-13 & (2) C-19 NETWORKED POWER OUTLET UNIT CUSTOMER DRAWING	
UNLESS OTHERWISE SPECIFIED, DIMENSIONAL TOLERANCES ARE: INCHES: X.X +/- 0.03, X.XX +/- 0.015, X.XXX +/- 0.005 [METRIC - MILLIMETER]: X +/- 0.8, X.X +/- 0.4, X.XX +/- 0.13 ANGLE: +/- 1°	
UNLESS OTHERWISE SPECIFIED, ALL DIMENSIONS ARE GIVEN IN INCHES, THIRD ANGLE PROJECTION	
DRAWN BY: MRWA DATE: 11-16-11 CHK'D: KRKE	
MAT'L: NONE	
SCALE: NONE	
DRAWING NO.: 09V098HP DWG SIZE: B	