


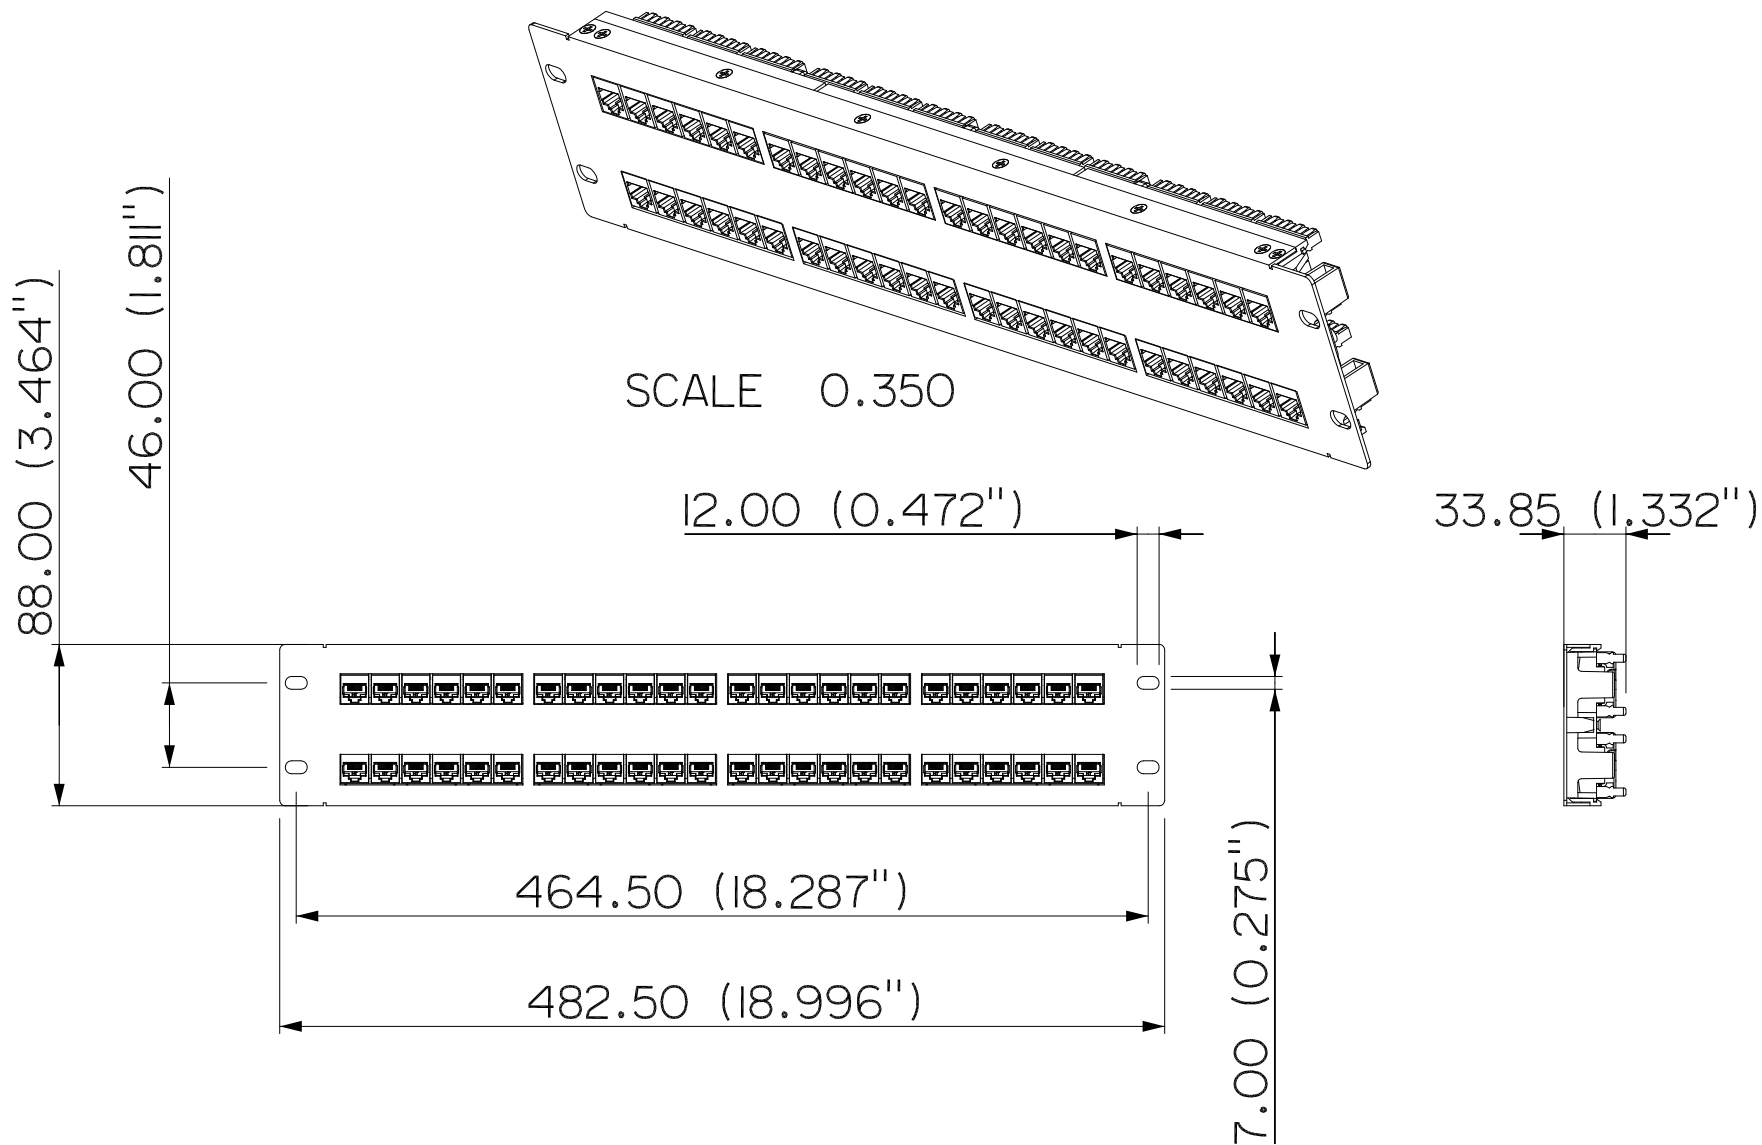

INVENTORS	HellermannTyton Structured Cabling Products			REVISION level 2 by S. PONTING date 19/05/14 ECN # part level	DIMENSIONS TOLERANCES unless otherwise specified units mm / inches	number P155-014	phase PRODUCTION	FORMAT AH version J	CAD PRO-E	scale 0.250	
	ALL PROPRIETARY RIGHTS IN THE SUBJECT MATTER SHOWN ON THIS DRAWING ARE EXCLUSIVE PROPERTY OF HELLERMANNTYTON					computer file number	previous number				
	Name	Date	City, State			drawn S. Ponting	checked	approved			
	S. PONTING	24/08/01	NORTHAMPTON U.K.			date 24/08/01	checked	approved			
						type CREO	sheet 1 of 1				
						material N/A		number P155-014			

PART

CAT 6 2U 48 PORT 110 UNIVERSAL PATCH PANEL

DRAWING